



PROPOSED FLOOR PLAN
SCALE 1/4"=1'-0"

1
A-030

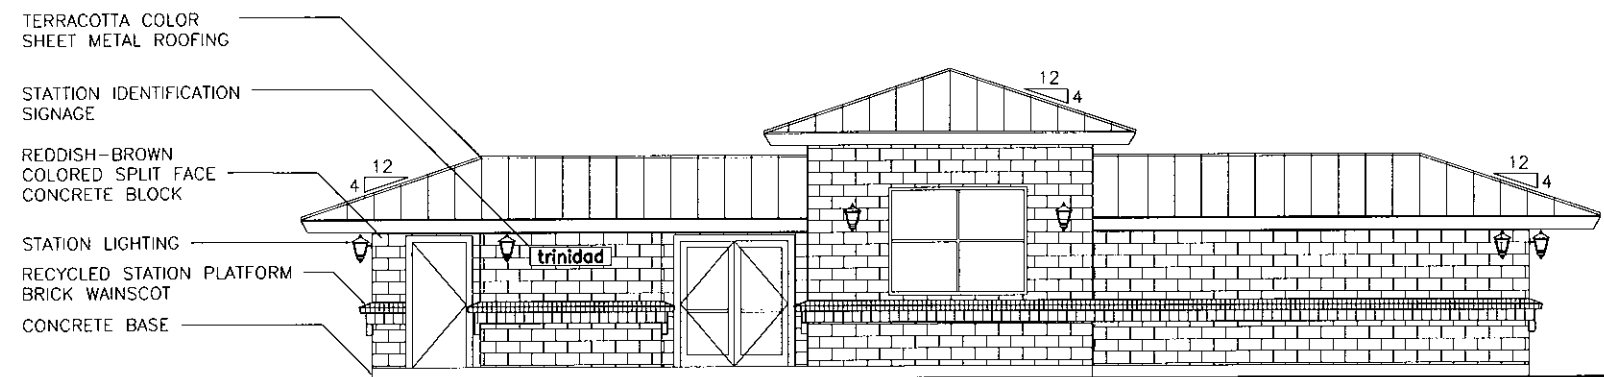

SOUTH SIDE ELEVATION
SCALE 3/16"=1'-0"

1
A-030

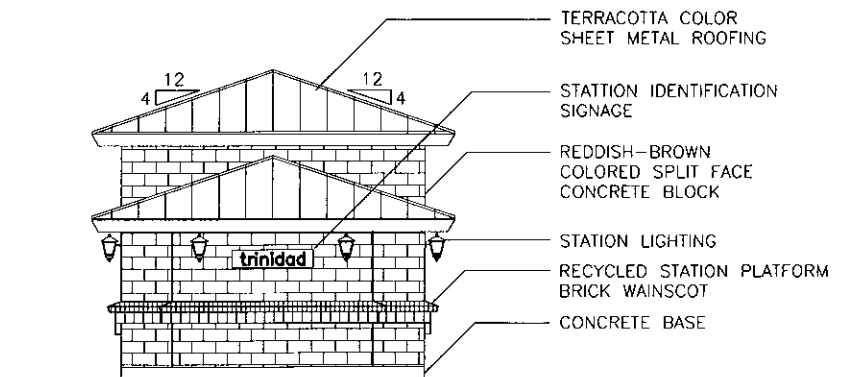

WEST SIDE ELEVATION
SCALE 3/16"=1'-0"

1
A-030

FILE NAME: A:\TCLG-2000.DWG

No.	Revisions	Date	By
1	BRIDGING FINAL	01/05/10	TO

Amtrak[®]

This material is owned by and is the sole and exclusive property of the National Railroad Passenger Corporation (Amtrak), Office of Engineering, and is supplied on a confidential basis solely for use in connection with the design and construction of Amtrak facilities and equipment. The reproduction, display, sale or other disposition of this document without the express written consent of the National Railroad Passenger Corporation, Office of Engineering, is prohibited.

Office of Chief Engineer

National Railroad Passenger Corporation
30th Street Station, Philadelphia, Pennsylvania 19104

Approved	Date

JACOBS[™]

INFORMATION CLASSIFICATION CATEGORY: CONFIDENTIAL INFORMATION


TRINIDAD, COLORADO
SMALL SHELTER/UNSTAFFED STATIONS
29116071

PROPOSED FLOOR PLAN AND ELEVATION

Designed RMD Draw RMD Checked TNO Date 1/29/2010

File No.	CO TRI
Function	3591
Work Elem. No.	275000
Sheet No.	OF 8

1
A-000

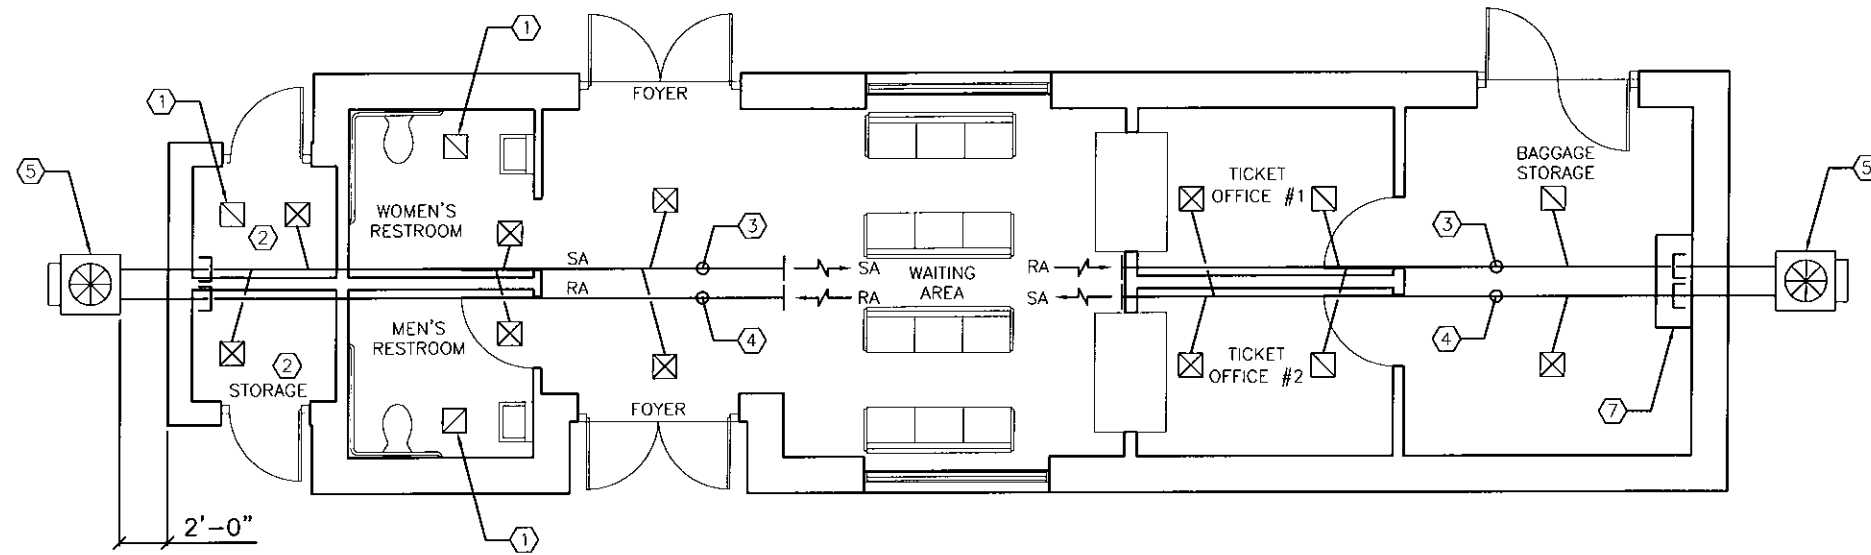


MECHANICAL WORK NOTES:

- ① 75 CFM EXHAUST FAN ABOVE CEILING, VENT-THRU-ROOF
- ② REDESIGN JAN. CLOSET/ STORAGE ROOM TO ACCOMODATE DUCT RISERS
- ③ SA ABOVE CEILING
- ④ RA ABOVE CEILING
- ⑤ GAS-FIRED, ELECTRIC DX COOLING PACKAGE HVAC UNIT.
- ⑥ CABINET OR BASEBOARD ELECTRIC HEATER.
- ⑦ ENCLOSED VERTICAL CHASE
- ⑧ INSULATED, WEATHERPROOF HORIZONTAL DUCT.

MECHANICAL LAYOUT

SCALE 1/4"=1'-0"


1
ME-010

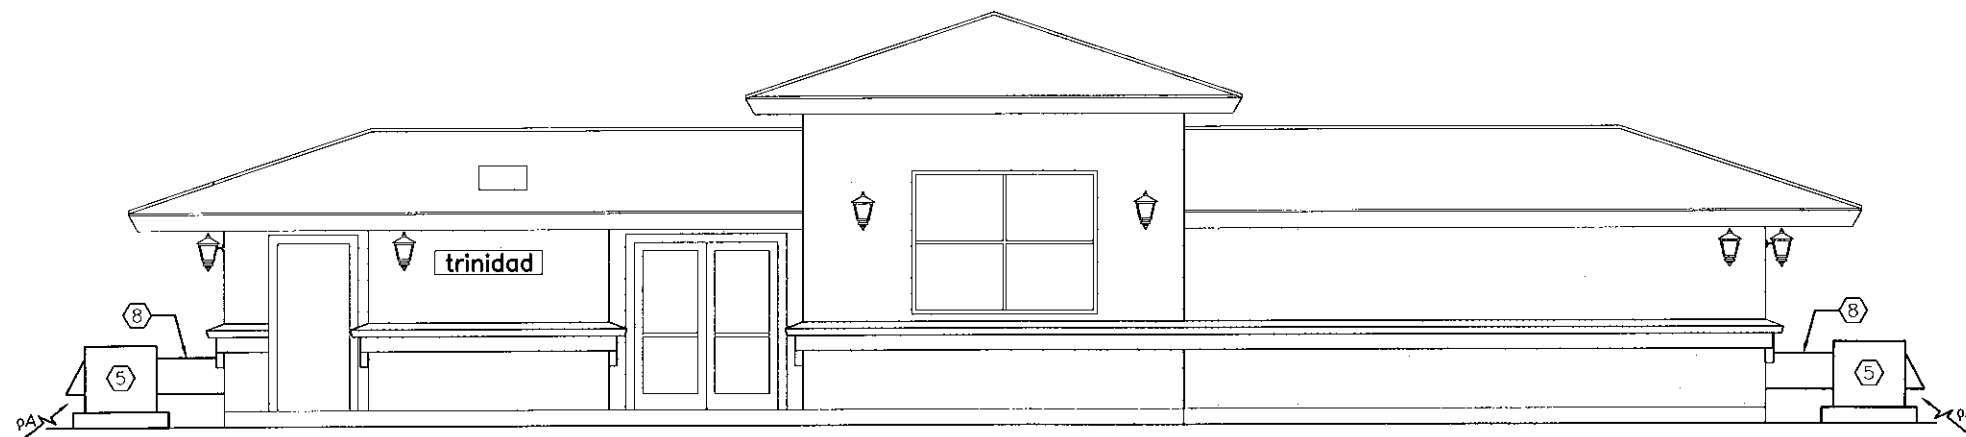

SOUTH SIDE ELEVATION

SCALE 1/4"=1'-0"

1
ME-010

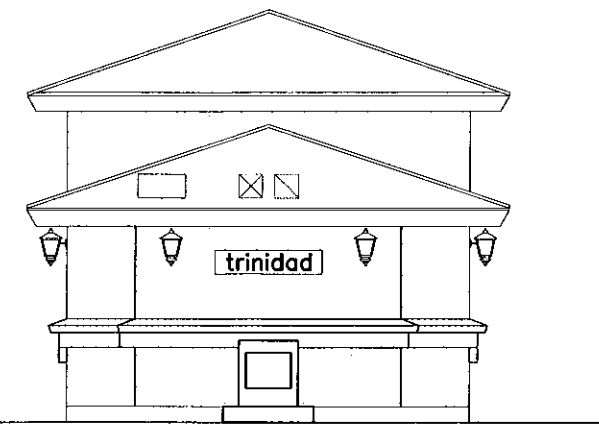


WEST SIDE ELEVATION

SCALE 1/4"=1'-0"

1
ME-010

FILE NAME: A:\TCLG-000.DWG
 PLOT SCALE: AS NOTED
 STANDARD PLOT TABLE: VTS

No.	Revisions	Date	By
1	BRIDGING FINAL	01/05/10	10

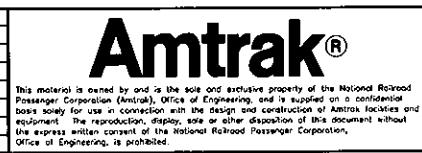

Office of Chief Engineer
 National Railroad Passenger Corporation
 30th Street Station, Philadelphia, Pennsylvania 19104

Approved	Date




INFORMATION CLASSIFICATION CATEGORY: CONFIDENTIAL INFORMATION

TRINIDAD, COLORADO
SMALL SHELTER/UNSTAFFED STATIONS
 29116071
MECHANICAL FLOOR PLAN AND ELEVATION

Designed RMD Drawn RMD Checked TNO Date 1/29/2010

File No.	CO, TRI
Function:	3591
Work Elem. No	275000
Sheet No.	OF 8

ME-010

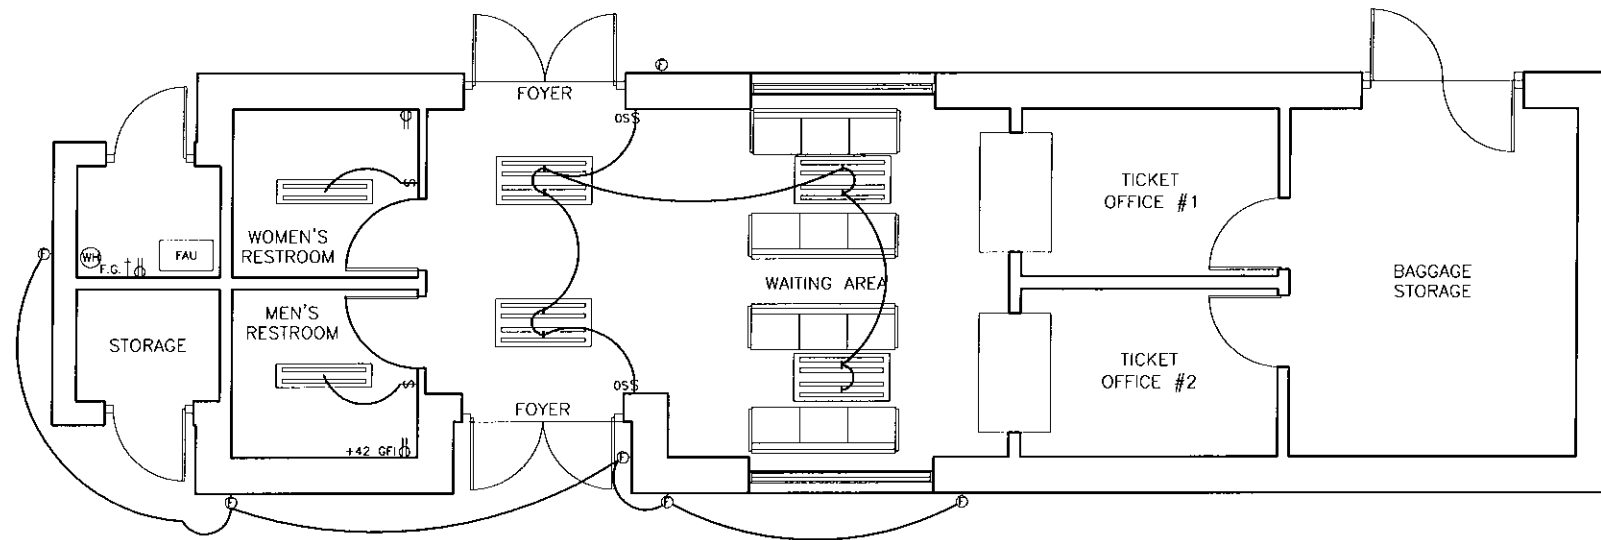

ELECTRICAL LAYOUT

SCALE 1/4"=1'-0"

1
E-020

MECHANICAL WORK NOTES:

1. SIZE AND PROVIDE NEW ELECTRICAL SERVICE AND PANEL BOARD INSIDE BAGGAGE/STORAGE AREA TO SUPPORT ELECTRICAL/MECHANICAL SITE DEMAND.
2. PROVIDE SIGNAGE ILLUMINATION ON EXTERIOR OF BUILDING.
3. PROVIDE PLATFORM LIGHTING PER AMTRAK STANDARDS SPD-ELC AND SP6004 AND ALL ASSOCIATED CABLE AND CONDUIT ALONG LENGTH OF PLATFORM.
4. INSTALL PID SYSTEM ALONG PLATFORM AND INSIDE STATION.
5. PROVIDE AMTRAK EMERGENCY PHONE ON FACE OF BUILDING.
6. PROVIDE EXTERIOR LIGHTING AROUND STATION, PARKING LOTS AND DRIVEWAYS TO COMPLY WITH AMTRAK STANDARD SPD-ELC AND SP6004.
7. PROVIDE INTERIOR STATION LIGHTING TO COMPLY WITH AMTRAK STANDARD SPD-ELC AND SP6004.
8. PROVIDE FIRE ALARM SYSTEM AND INTRUSION DETECTION SYSTEM THROUGHOUT PASSENGER STATION.
9. INSTALL NEW EMERGENCY LIGHTING AND EXITS SIGNS, LIGHTING, RECEPTACLES AND VOICE/DATA TO COMPLY WITH AMTRAK STANDARDS.
10. FURNISH AND SUPPLY TTY/TTD TELEPHONE INSIDE STATION WAITING AREA.

FILE NAME: AL_TCLG-2007.MWG
PLOT SCALE: AS NOTED
STANDARD PEN TABLE: TFS

No.	Revisions	Date	By
1	BRIDGING FINAL	01/05/10	TO

Amtrak[®]

This material is owned by and is the sole and exclusive property of the National Railroad Passenger Corporation (Amtrak), Office of Engineering, and is supplied on a confidential basis solely for use in connection with the design and construction of Amtrak facilities and equipment. The reproduction, copying, sale or other disposition of this document without the express written consent of the National Railroad Passenger Corporation, Office of Engineering, is prohibited.

Office of Chief Engineer

National Railroad Passenger Corporation
30th Street Station, Philadelphia, Pennsylvania 19104

Approved	Date

JACOBS[™]

TRINIDAD, COLORADO
SMALL SHELTER/UNSTAFFED STATIONS
29116071

ELECTRICAL FLOOR PLAN

Designed RMD Draw RMD Checked TNO Date 1/29/2010

File No:	CO, TRI
Function:	3591
Work Elem. No.:	275000
Sheet No.:	OF 8
	E-020

INFORMATION CLASSIFICATION CATEGORY: CONFIDENTIAL INFORMATION